

---

## Addendum No. 2

Date: *May 26, 2023*

Solicitation Number: *FY23-ITBCON-35*

Title: *Franklin Water Treatment Plant Clearwell Improvements*

Issued by: *Mike Benchich*  
*mbenchich@hazenandsawyer.com*

---

Bidders should acknowledge receipt of this addendum on the Bid Form. Failure to acknowledge receipt of this addendum may result in the bid not being considered.

All Bidders are responsible for monitoring CLTWater's Contracting Opportunities website ([Invitation to bid \(ITB\) - City of Charlotte \(charlottenc.gov\)](https://www.charlottenc.gov/procurement/contracting-opportunities)) for additional changes or clarifications.


### **Modifications to the Invitation to Bid:**

#	Contract Sheet # and Title	Revision #	Modification
1	G2, General Abbreviations and Legend	Revision No. 4	In the NOTES section, <b>add</b> the following note:  "3. The Owner will permit the Contractor to use the 3-ton monorail crane in the Control Building basement provided it is operated by a qualified individual. Any damage to the crane or monorail resulting from the Contractor's use shall be repaired at no cost to the Owner."
2	C41, Yard Piping Civil Enlarged Site Plan – Area 1	Revision No. 3	<b>Replace</b> Contract Drawing C41 in its entirety with the attached Contract Drawing C41. The Contract Drawing has been revised to show two new fire hydrants connected via tapping sleeve to existing raw water lines.
3	C55, Yard Piping Civil Details	Revision No. 3	<b>Add</b> the attached Detail 17 to Contract Drawing C55.

----- END OF ADDENDUM NO. 2 -----

**The below listed attachments follow:**

- **Contract Drawing C41**
- **Detail 17 (for Contract Drawing C55)**

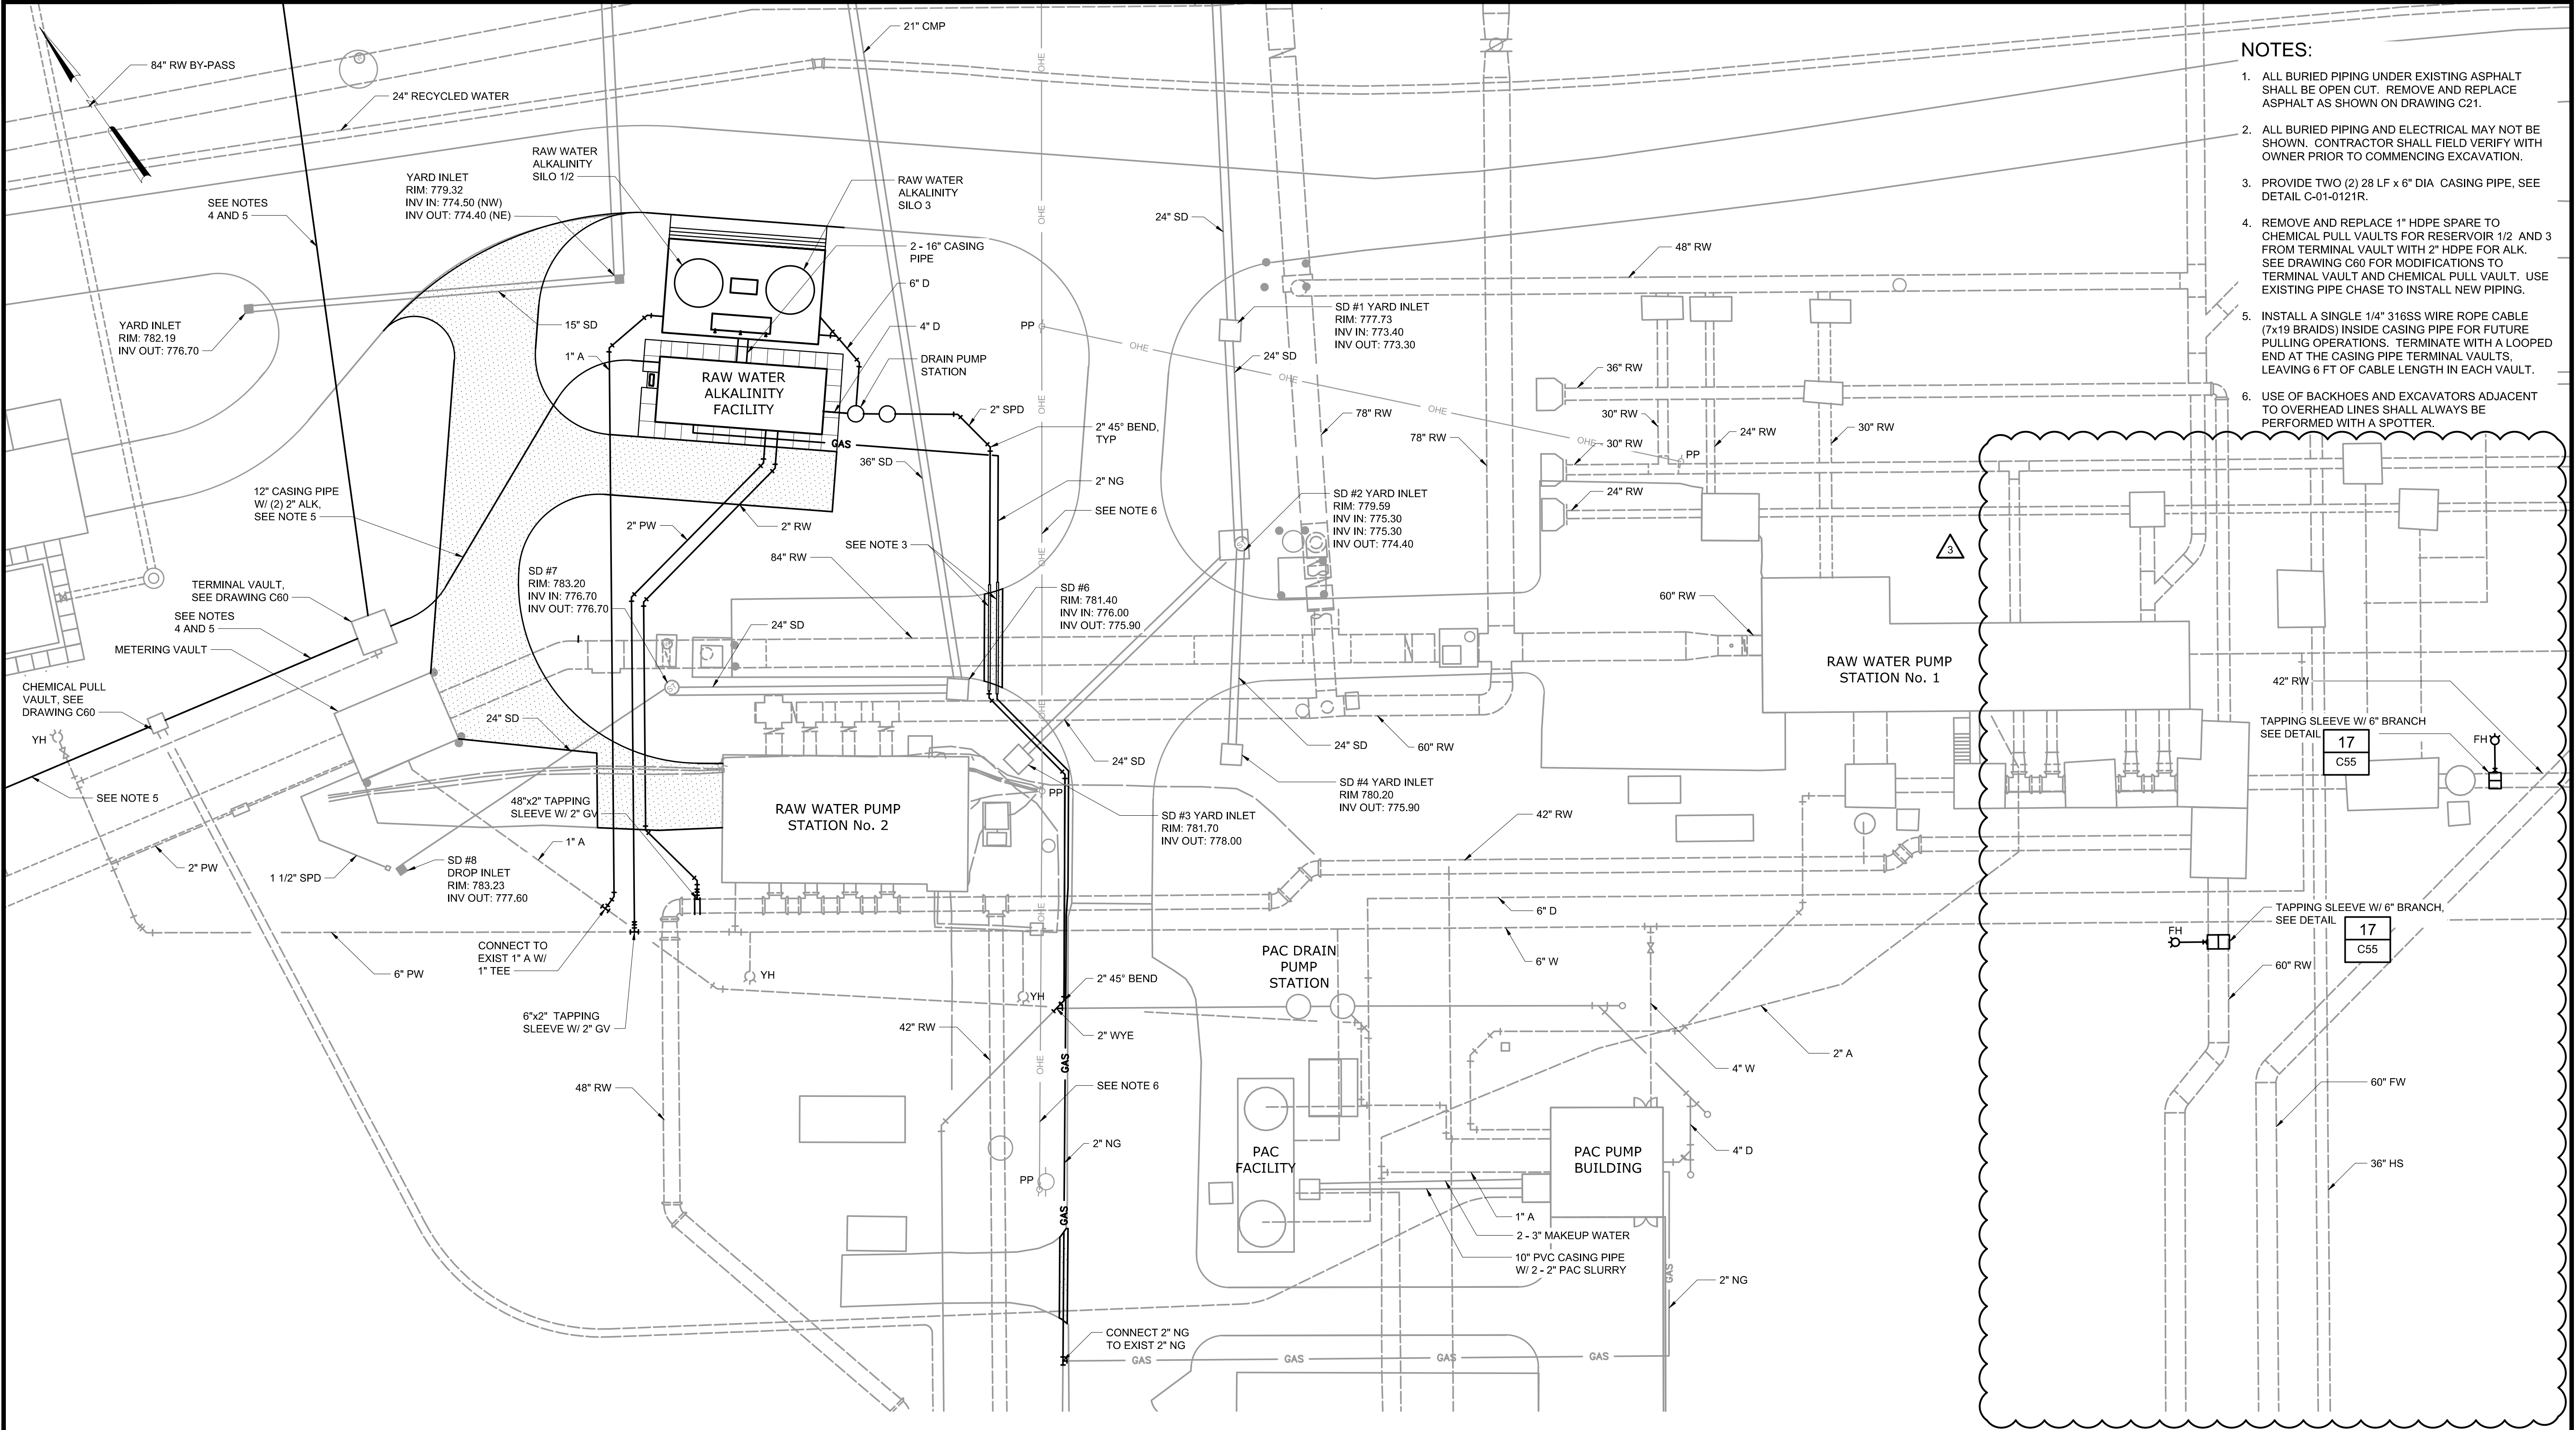


- NOTES:
1. ALL BURIED PIPING UNDER EXISTING ASPHALT SHALL BE OPEN CUT. REMOVE AND REPLACE ASPHALT AS SHOWN ON DRAWING C21.
  2. ALL BURIED PIPING AND ELECTRICAL MAY NOT BE SHOWN. CONTRACTOR SHALL FIELD VERIFY WITH OWNER PRIOR TO COMMENCING EXCAVATION.
  3. PROVIDE TWO (2) 28 LF x 6" DIA. CASING PIPE, SEE DETAIL C-01-0121R.
  4. REMOVE AND REPLACE 1" HDPE SPARE TO CHEMICAL PULL VAULTS FOR RESERVOIR 1/2 AND 3 FROM TERMINAL VAULT WITH 2" HDPE FOR ALK. SEE DRAWING C60 FOR MODIFICATIONS TO TERMINAL VAULT AND CHEMICAL PULL VAULT. USE EXISTING PIPE CHASE TO INSTALL NEW PIPING.
  5. INSTALL A SINGLE 1/4" 316SS WIRE ROPE CABLE (7x19 BRAIDS) INSIDE CASING PIPE FOR FUTURE PULLING OPERATIONS. TERMINATE WITH A LOOPED END AT THE CASING PIPE TERMINAL VAULTS. LEAVING 6 FT OF CABLE LENGTH IN EACH VAULT.
  6. USE OF BACKHOES AND EXCAVATORS ADJACENT TO OVERHEAD LINES SHALL ALWAYS BE PERFORMED WITH A SPOTTER.

ENLARGED SITE PLAN - AREA 1  
1" = 20'

1" = 20'-0"

				PROJECT ENGINEER:	M. BENCHICH
				DESIGNED BY:	M. BENCHICH
				DRAWN BY:	M. KARMANOCKY
				CHECKED BY:	M. BUSWELL
3	ADDENDUM NO. 2	5/2023	MJB	IF THIS BAR DOES NOT MEASURE 1" THEN DRAWING IS NOT TO FULL SCALE	
2	CONSTRUCTION	4/2023	MJB		
1	REGULATORY APPROVAL	2/8/2023	MJB		
REV	ISSUED FOR	DATE	BY		

THIS DOCUMENT ORIGINALLY ISSUED FOR CONSTRUCTION AND SEALED BY MICHAEL J. BENCHICH, SEAL NUMBER 032685.

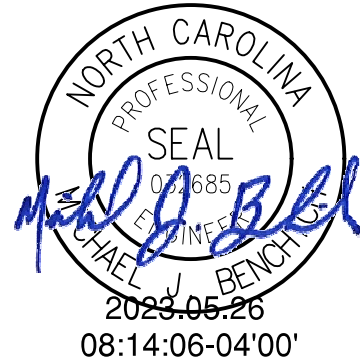

**Hazen**

HAZEN AND SAWYER  
9101 SOUTHERN PINE BOULEVARD  
CHARLOTTE, NORTH CAROLINA 28273  
LICENSE NO.: C-0381


CHARLOTTE WATER  
CHARLOTTE, NORTH CAROLINA

FRANKLIN WATER TREATMENT PLANT  
CLEARWELL IMPROVEMENTS

YARD PIPING  
CIVIL  
ENLARGED SITE PLAN - AREA 1

DATE:	APRIL 2023
HAZEN NO.:	30563-027
CONTRACT NO.:	1
DRAWING NUMBER:	

3

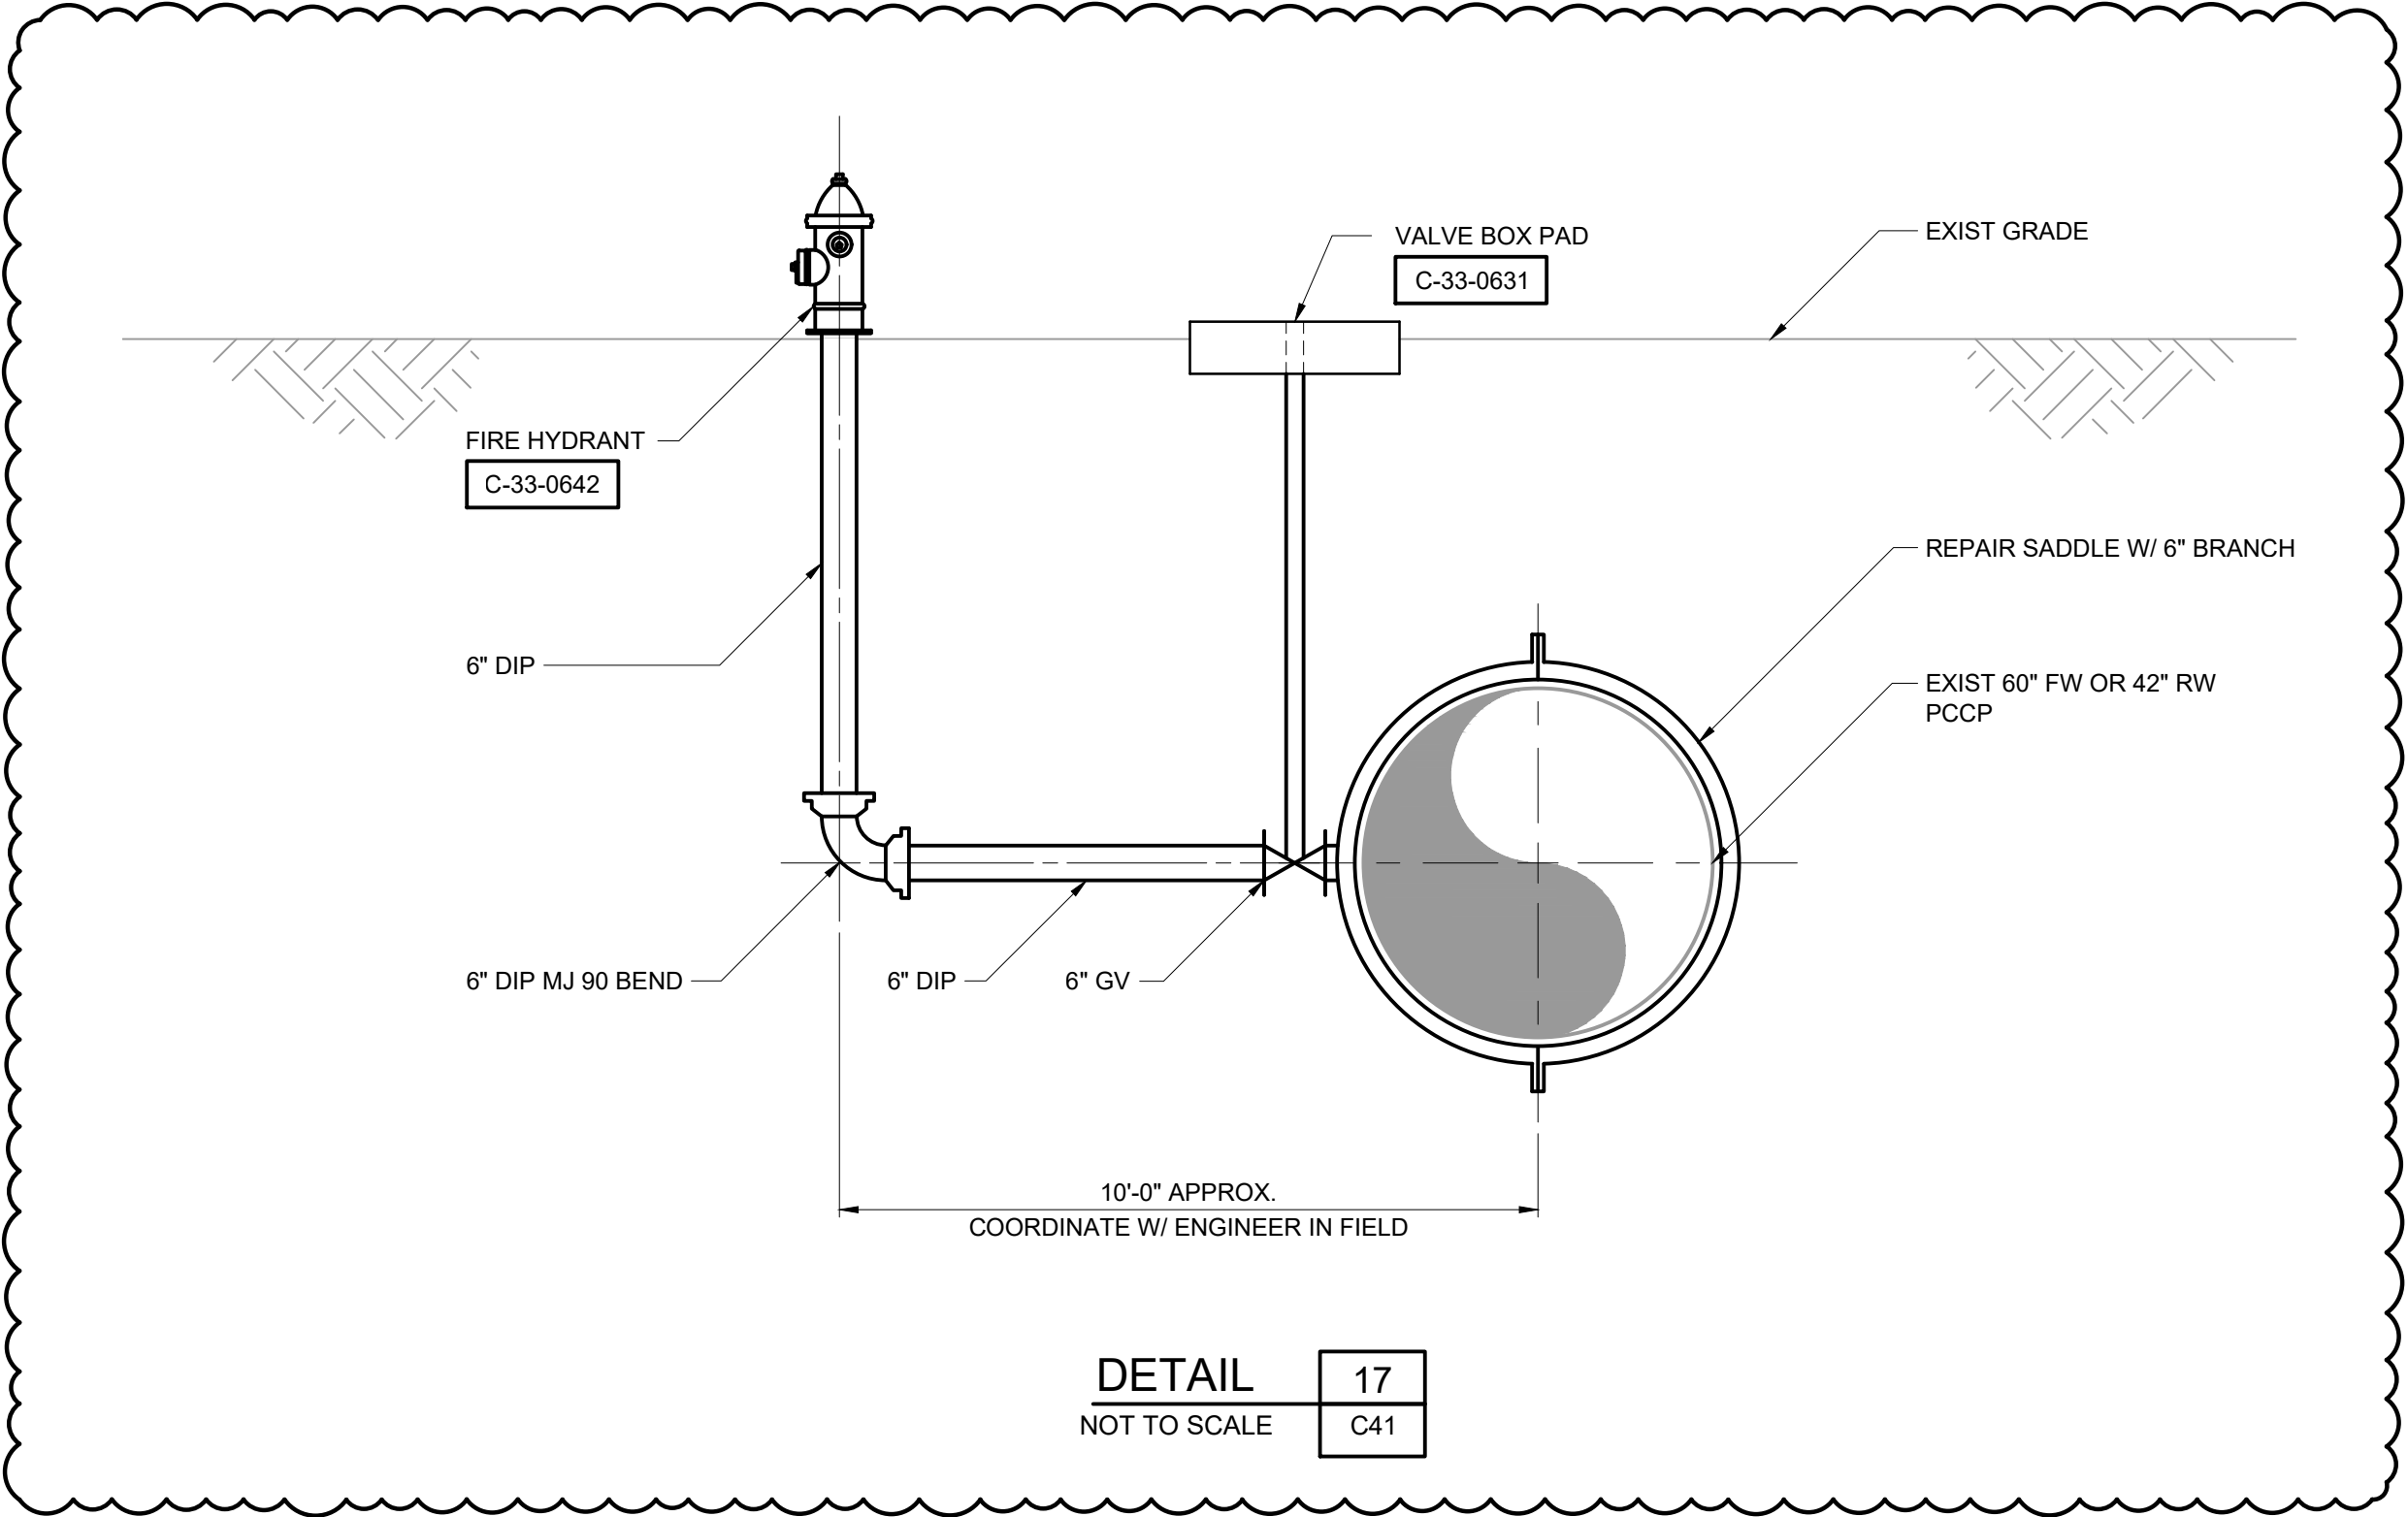

DETAIL  
NOT TO SCALE

17
C41

ADDENDA NO. 2	DATE 05/22/2023	CHARLOTTE WATER CHARLOTTE, NORTH CAROLINA	HAZEN JOB NUMBER 30563-027	REFER TO CONTRACT DRAWING NUMBER C55
ATTACHMENT NO. 1	BY MJB	FRANKLIN WATER TREATMENT PLANT CLEARWELL IMPROVEMENTS	CONTRACT NUMBER 30563-027	SHEET 1 OF 1